



**E** PROPOSED ATTENUATION TANK & SERVICES CROSS SECTION

003 SCALE 1:50  
SECTION ALSO RELEVANT TO DRAWINGS 152217-072/073/074/075

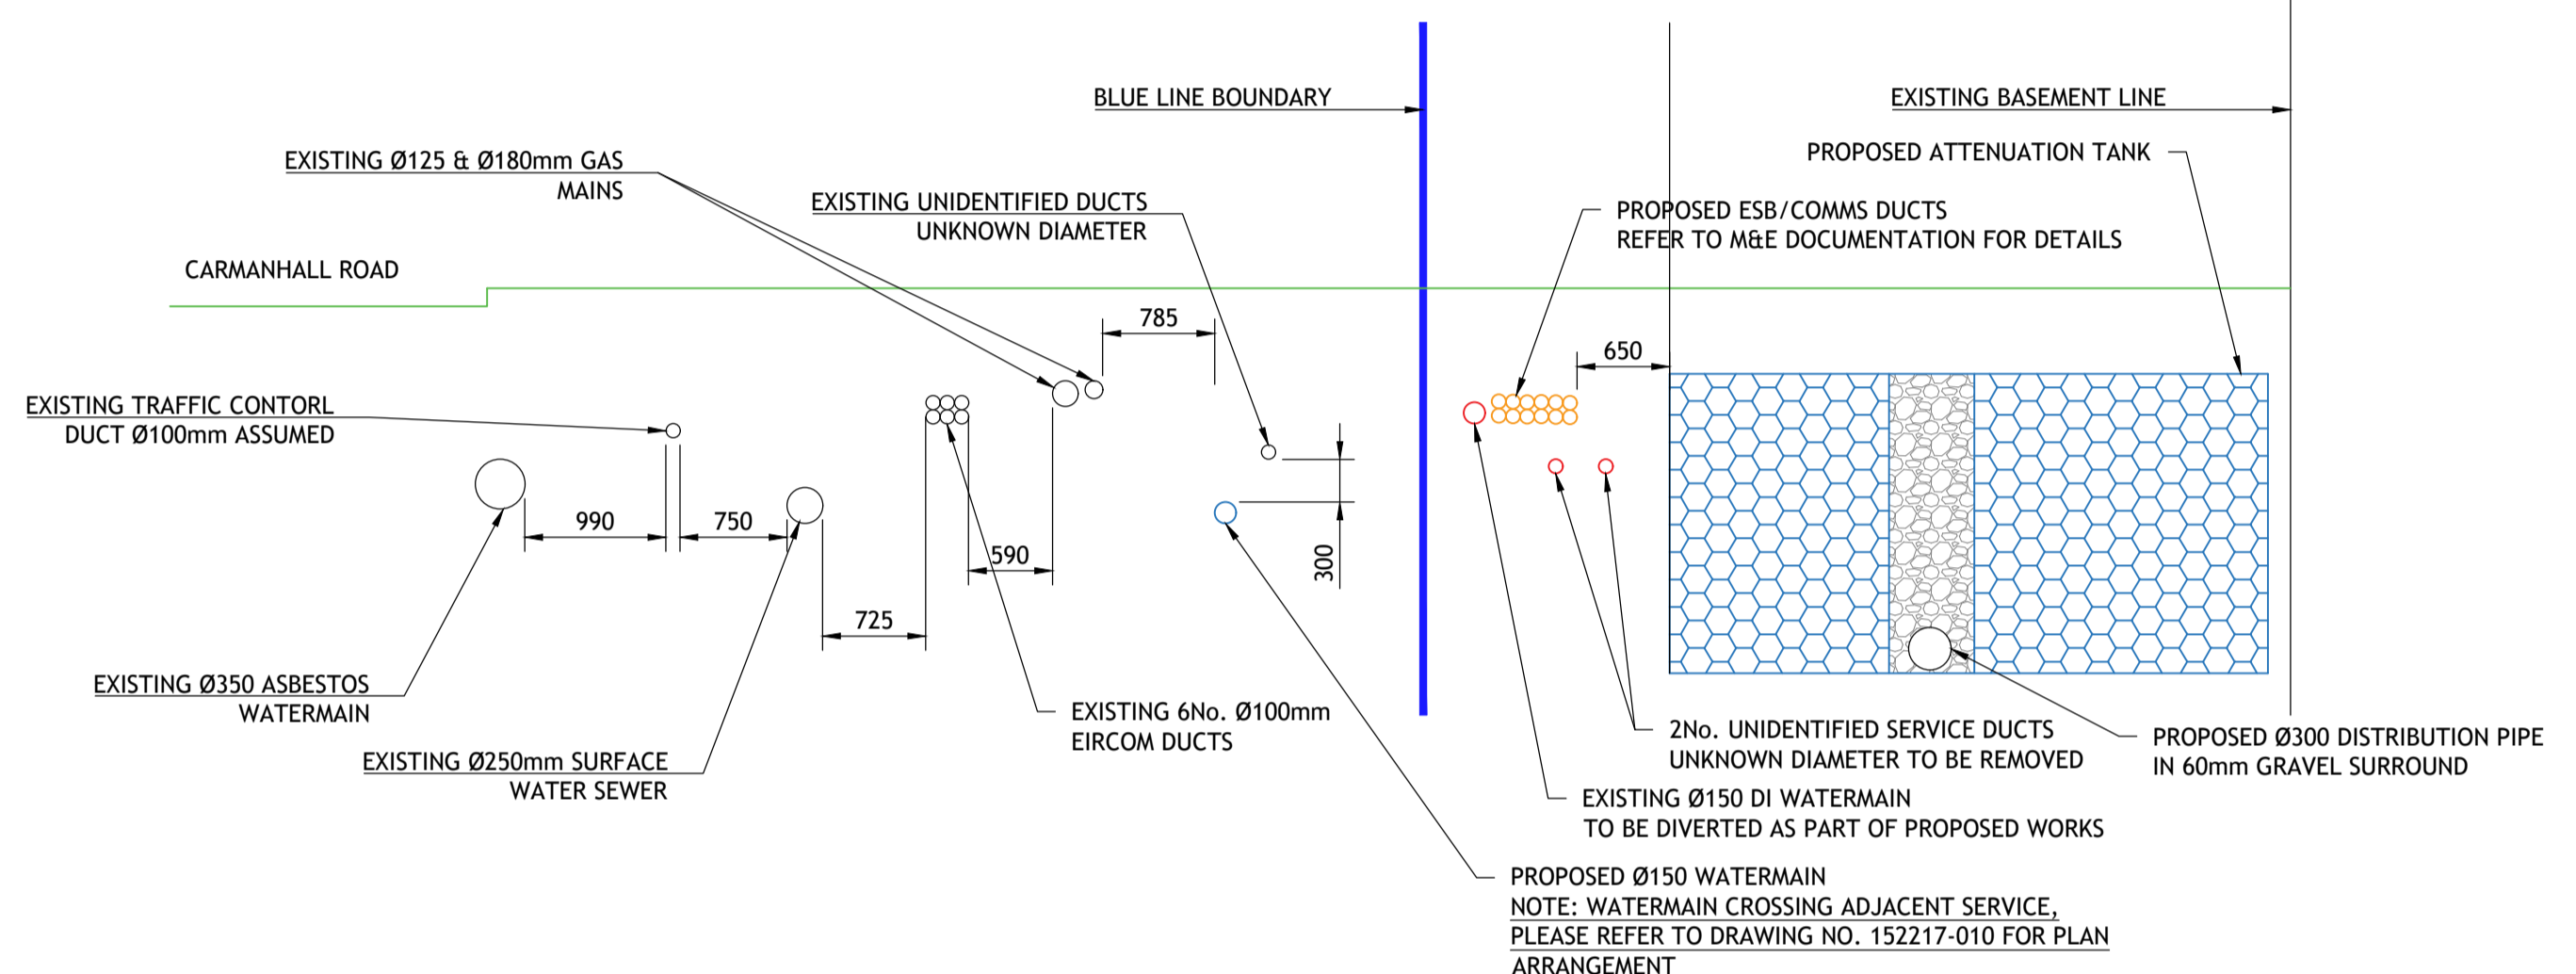


**F** PROPOSED ATTENUATION TANK & SERVICES CROSS SECTION

003 SCALE 1:50  
SECTION ALSO RELEVANT TO DRAWINGS 152217-072/073/074/075

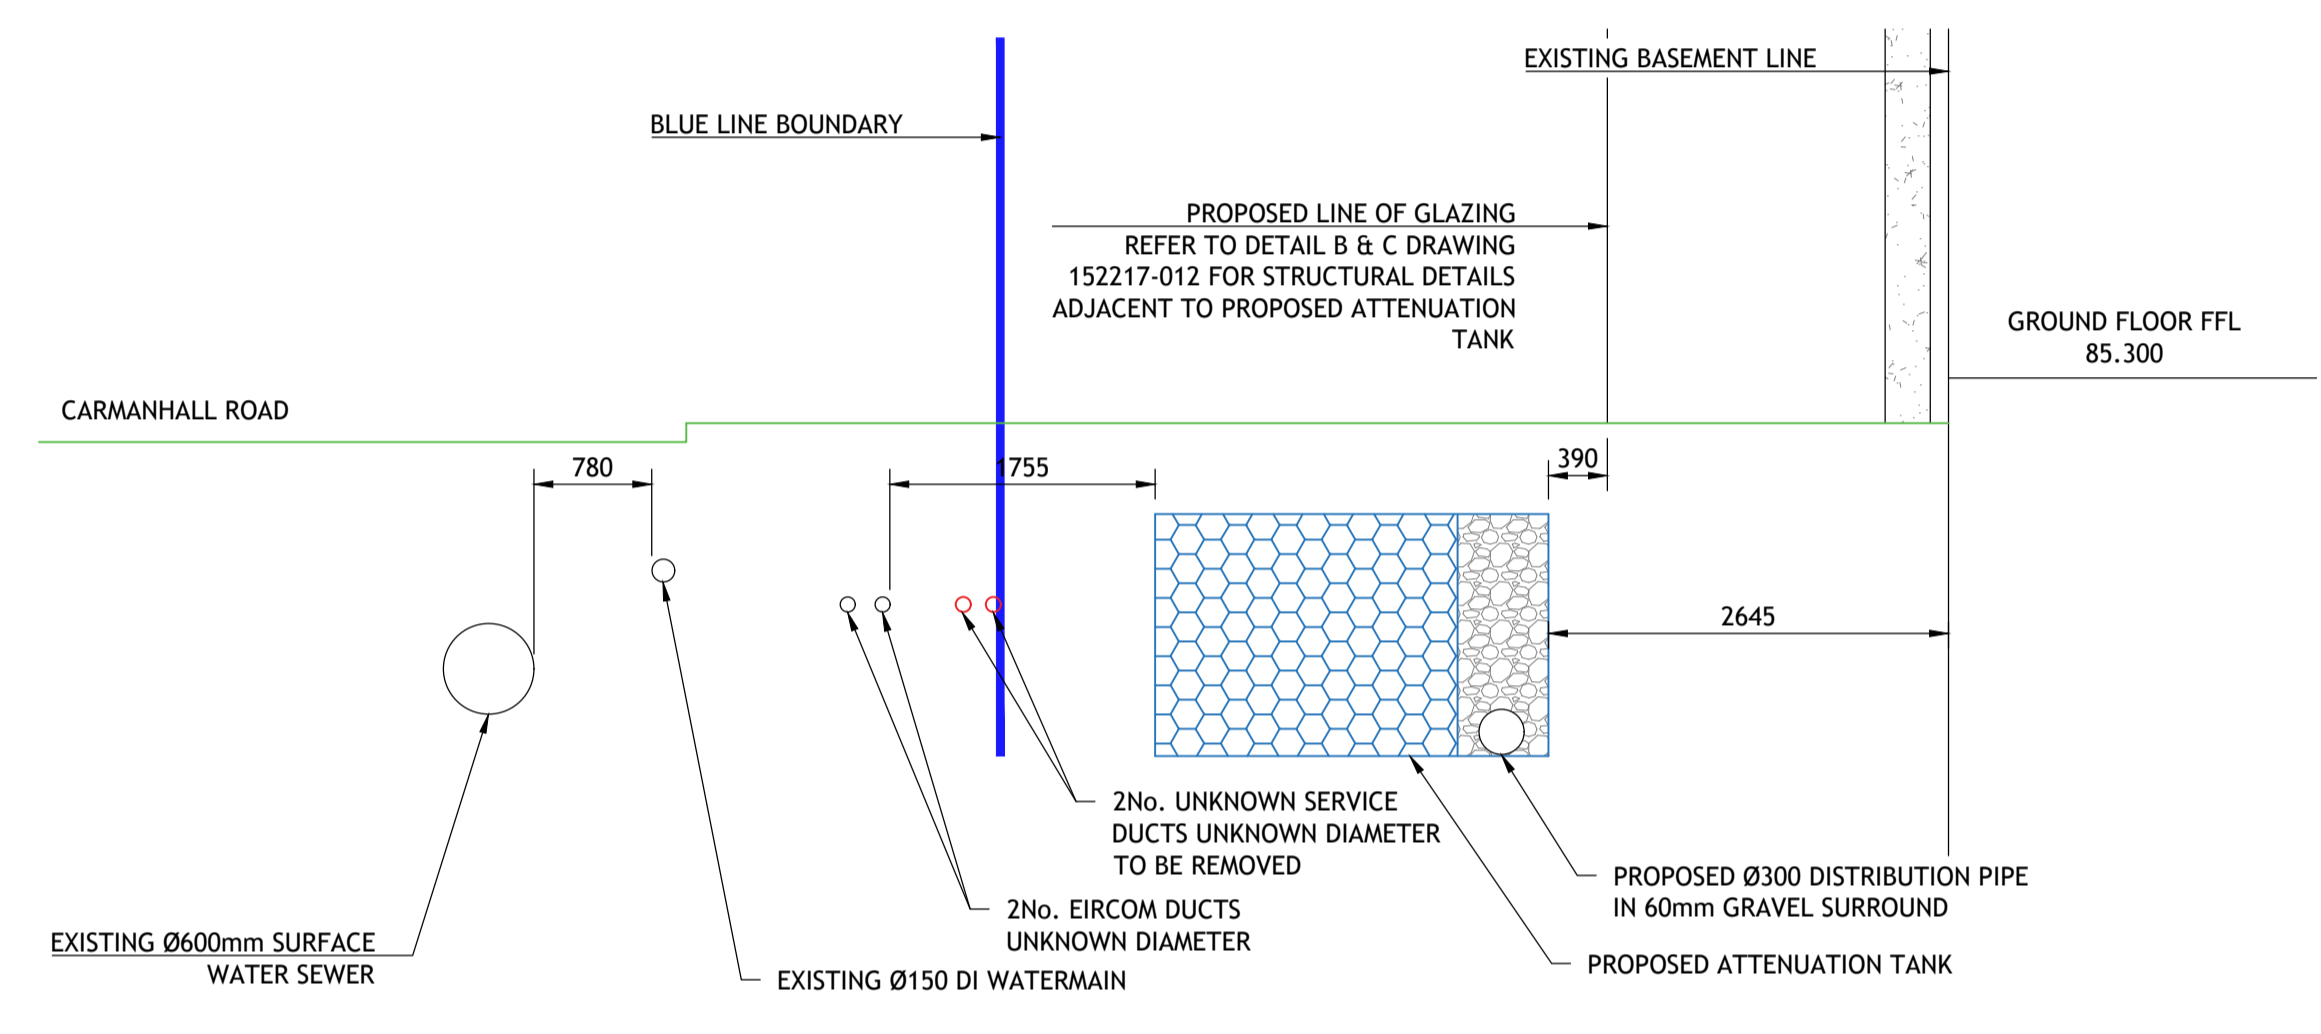

**G** PROPOSED ATTENUATION TANK & SERVICES CROSS SECTION


003 SCALE 1:50  
SECTION ALSO RELEVANT TO DRAWINGS 152217-072/073/074/075

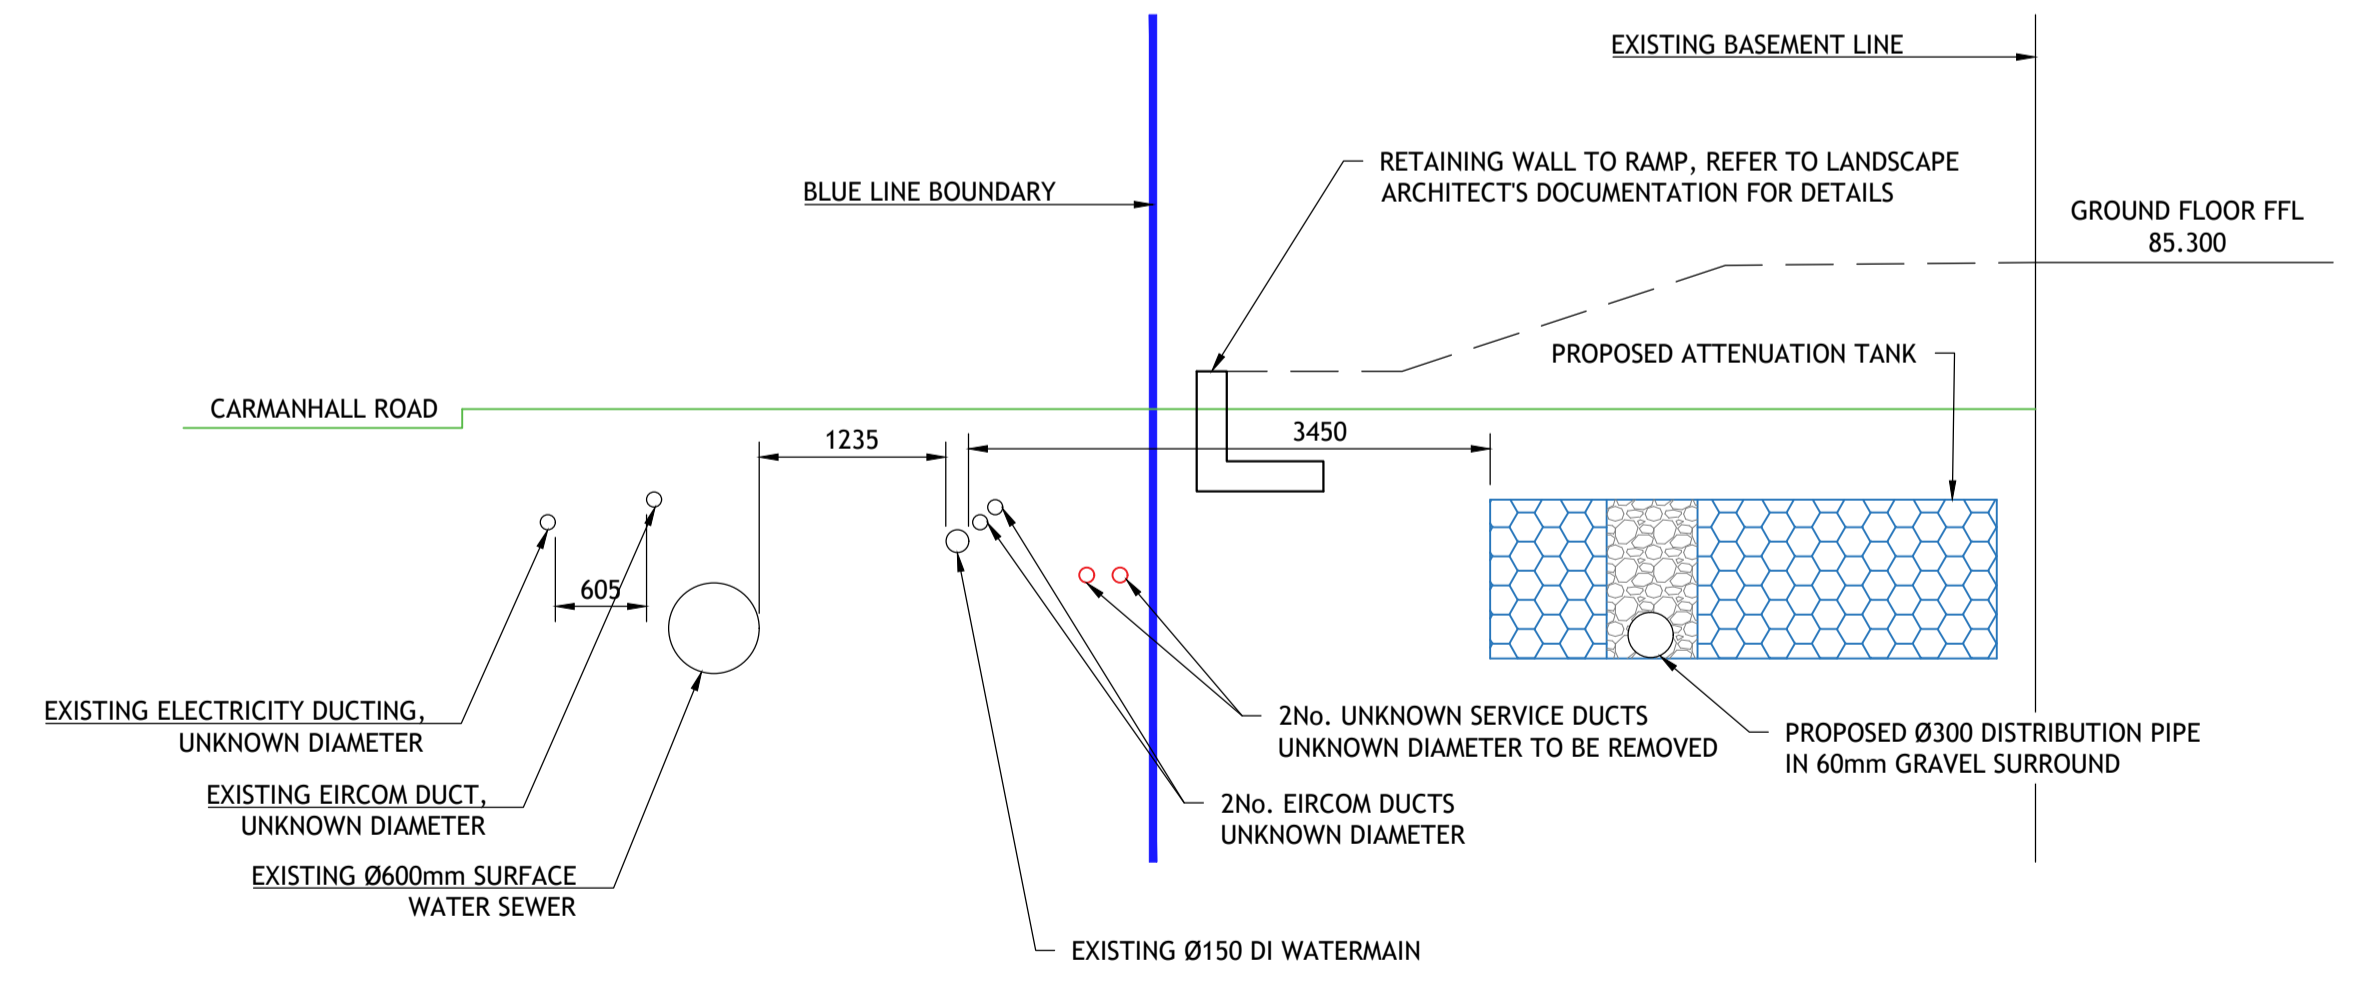

**H** PROPOSED ATTENUATION TANK & SERVICES CROSS SECTION

003 SCALE 1:50  
SECTION ALSO RELEVANT TO DRAWINGS 152217-072/073/074/075

- NOTES:**
1. THIS DRAWING IS TO BE READ IN CONJUNCTION WITH OVERALL GROUND FLOOR DRAINAGE LAYOUT DRAWING NO. 152217-003.
  2. ALL DIMENSIONS IN MILLIMETERS UNLESS NOTED OTHERWISE.
  3. ALL LEVELS IN METERS RELATING TO MALIN HEAD ORDNANCE DATUM UNLESS NOTED OTHERWISE.
  4. FOR DRAINAGE DETAILS REFER TO DRAWING NO. 152217-021.
  5. FOR IRISH WATER DETAILS REFER TO DRAWING NO. 152217-022.

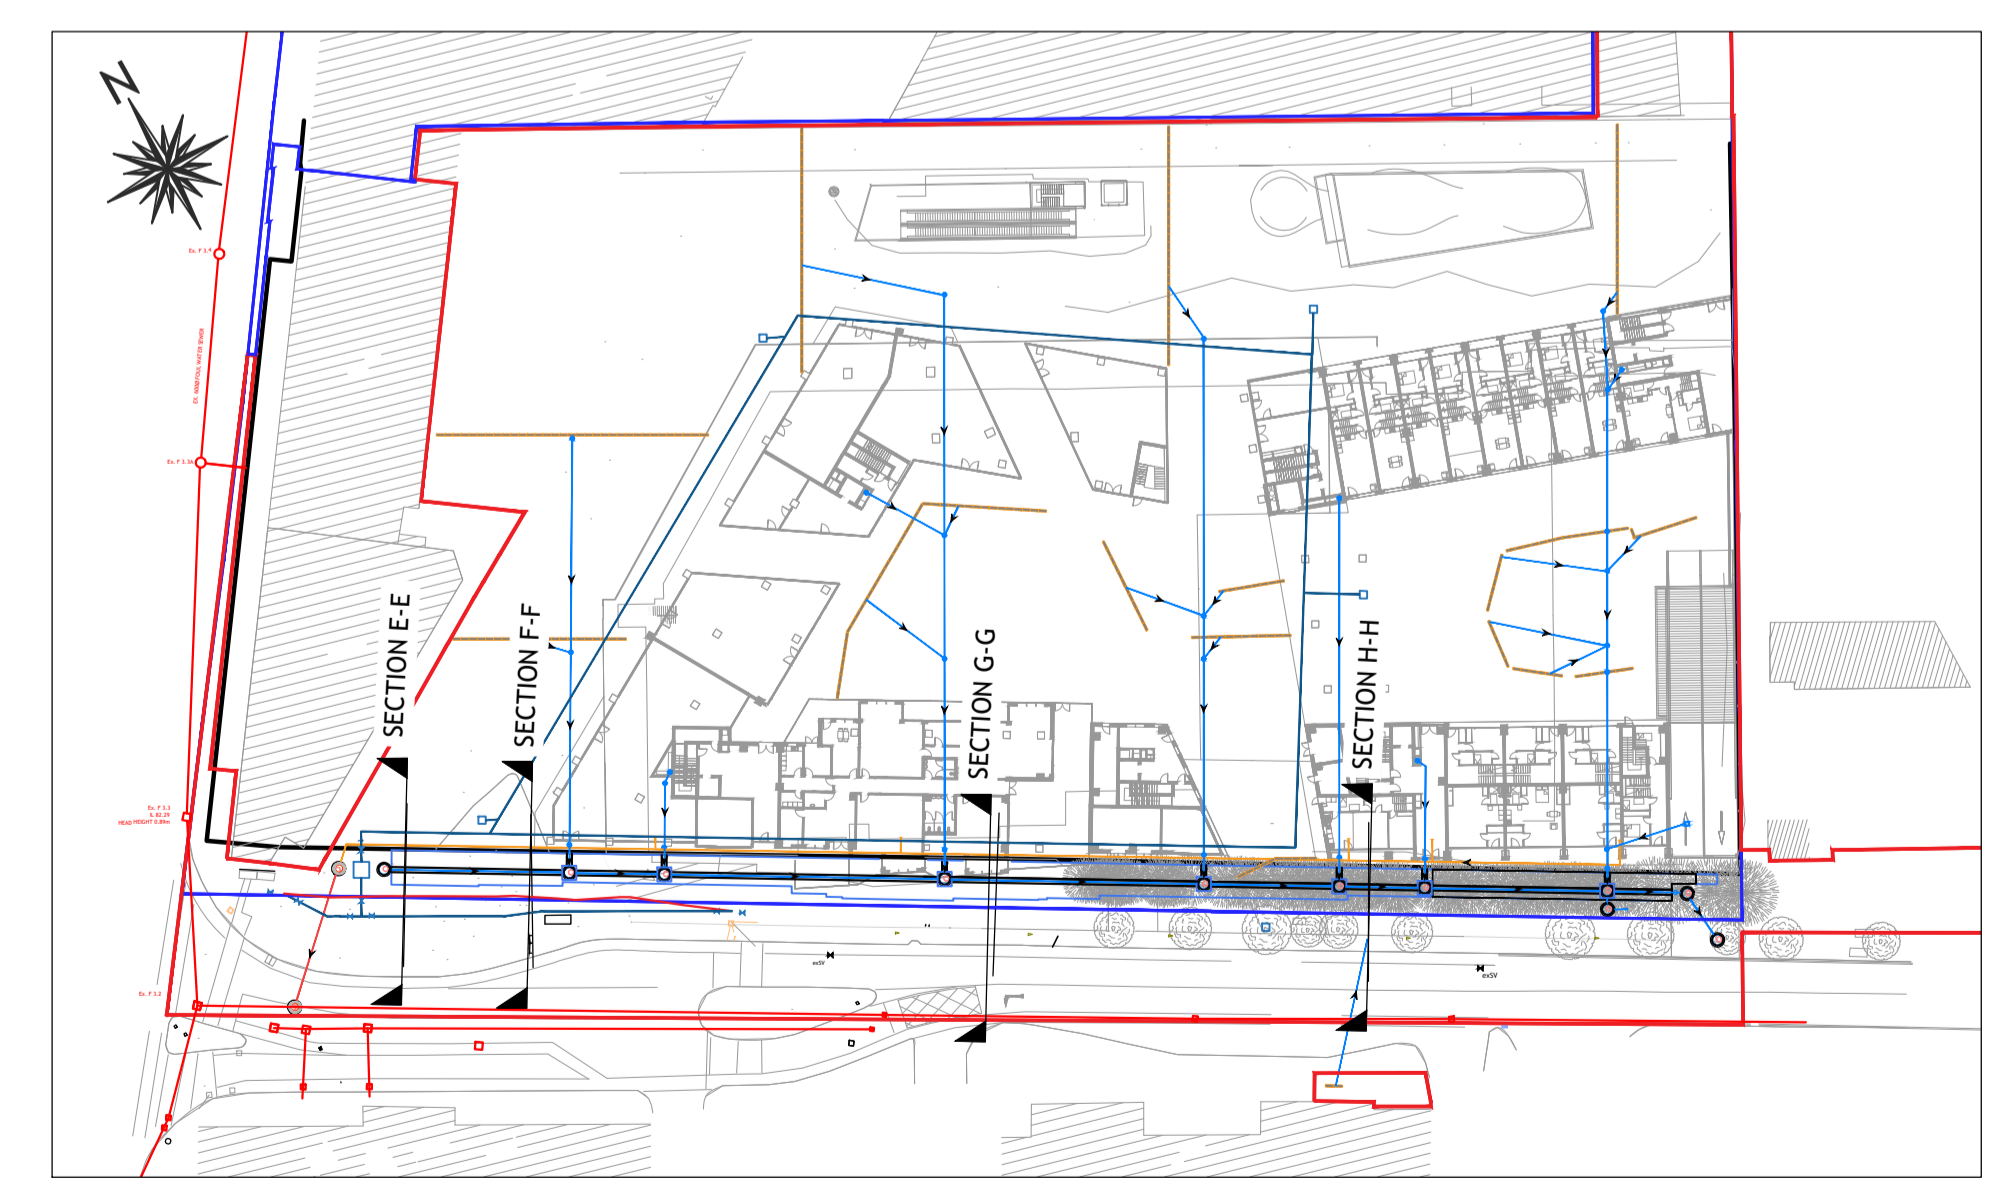

**LOCATION PLAN**  
NOT TO SCALE

© PUNCH Consulting Engineers

This drawing and any design hereon is the copyright of the Consultants and must not be reproduced without their written consent. All drawings remain the property of the Consultants. Figured dimension only to be taken from this drawing. Consultants to be informed immediately of any discrepancies before work proceeds.

Date Drawn:	JULY 2018
Drawn By:	IBS
Date Issued:	2019/04/12
Issued By:	IBS

Rev	Amendment	By	Date
PL0	ISSUED FOR PLANNING	IBS	2019/03/25
PL1	ISSUED FOR PLANNING	IBS	2019/03/29
PL2	ISSUED FOR PLANNING	IBS	2019/04/05
PL3	ISSUED FOR PLANNING	IBS	2019/04/12

Client:  
**IRES Residential Properties LTD.**

Job: LANDS KNOWN AS "RB CENTRAL" AT ROCKBROOK, CARMANHALL ROAD, SANDYFORD BUSINESS DISTRICT, SANDYFORD, DUBLIN 18

Title: **ATTENUATION TANK/SERVICES CROSS SECTION**

**PUNCH** consulting engineers | Dublin | Limerick | Cork | Galway | Glasgow

Carmegie House, Library Road, Dun Laoghaire, Co. Dublin, A96 C7W7  
IRL: +353 1 271 2200 www.punchconsulting.com

Stage:	PLANNING
Scale @ A1:	AS SHOWN
Technician Check:	IBS
Engineer Check:	MR
Approved:	PC
Drawing No:	152217-015
Rev:	PL3