


INDICATIVE LAYOUT ONLY

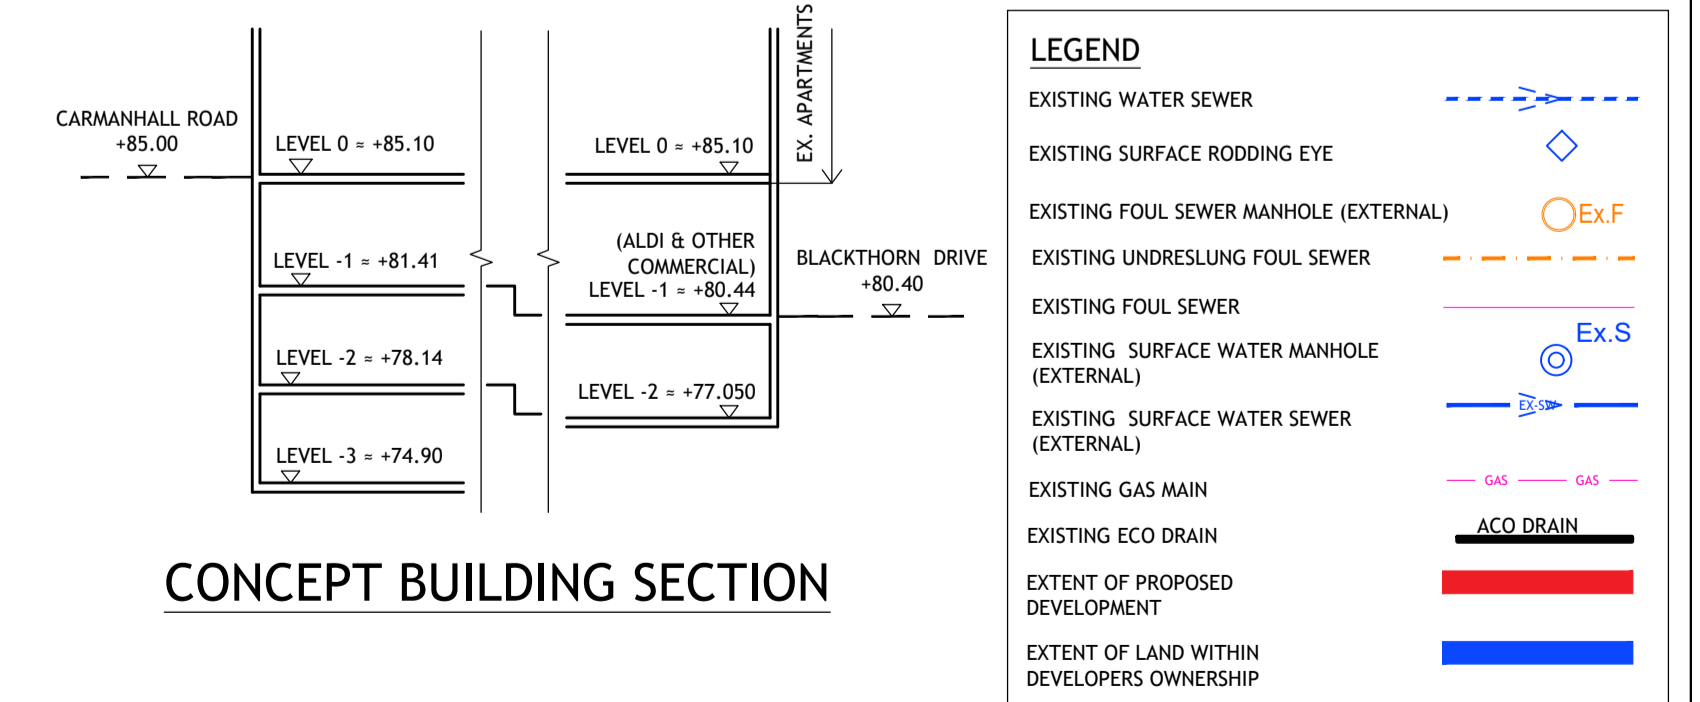

CONCEPT BUILDING SECTION

LEGEND	
EXISTING WATER SEWER	
EXISTING SURFACE RODDING EYE	
EXISTING FOUL SEWER MANHOLE (EXTERNAL)	
EXISTING UNDRRESSING FOUL SEWER	
EXISTING FOUL SEWER	
EXISTING SURFACE WATER MANHOLE (EXTERNAL)	
EXISTING SURFACE WATER SEWER (EXTERNAL)	
EXISTING GAS MAIN	
EXISTING ECO DRAIN	
EXTENT OF PROPOSED DEVELOPMENT	
EXTENT OF LAND WITHIN DEVELOPERS OWNERSHIP	

© PUNCH Consulting Engineers
 This drawing and any design hereon is the copyright of the Consultants and must not be reproduced without their written consent.
 All drawings remain the property of the Consultants. Figured dimension only to be taken from this drawing. Consultants to be informed immediately of any discrepancies before work proceeds.

Date Drawn: JULY 2018
 Drawn By: IBS
 Date Issued: 2019/04/12
 Issued By: IBS



Rev	Amendment	By	Date
PL0	ISSUED FOR PLANNING	IBS	2018/12/06
PL1	ISSUED FOR PLANNING	IBS	2019/03/29
PL2	ISSUED FOR PLANNING	IBS	2019/04/12

Client:
 IRES Residential Properties LTD.

Job: LANDS KNOWN AS "RB CENTRAL" AT ROCKBROOK, CARMANHALL ROAD, SANDYFORD BUSINESS DISTRICT, SANDYFORD, DUBLIN 18
 Title: EXISTING DRAINAGE LAYOUT - BASEMENT -2 SH 1 OF 2
 Stage: PLANNING
 Scale @ A1: 1:250
 Technician Check: IBS
 Engineer Check: MR
 Approved: PC
 Drawing No: 152217-064
 Rev: PL2

PUNCH consulting engineers
 Dublin | Limerick | Cork | Galway | Glasgow
 Carnegie House, Library Road, Dun Laoghaire, Co. Dublin, A96 C7W7
 IRL: +353 1 271 2200 www.punchconsulting.com