


SITE PLAN LAYOUT NTS

INDICATIVE LAYOUT ONLY

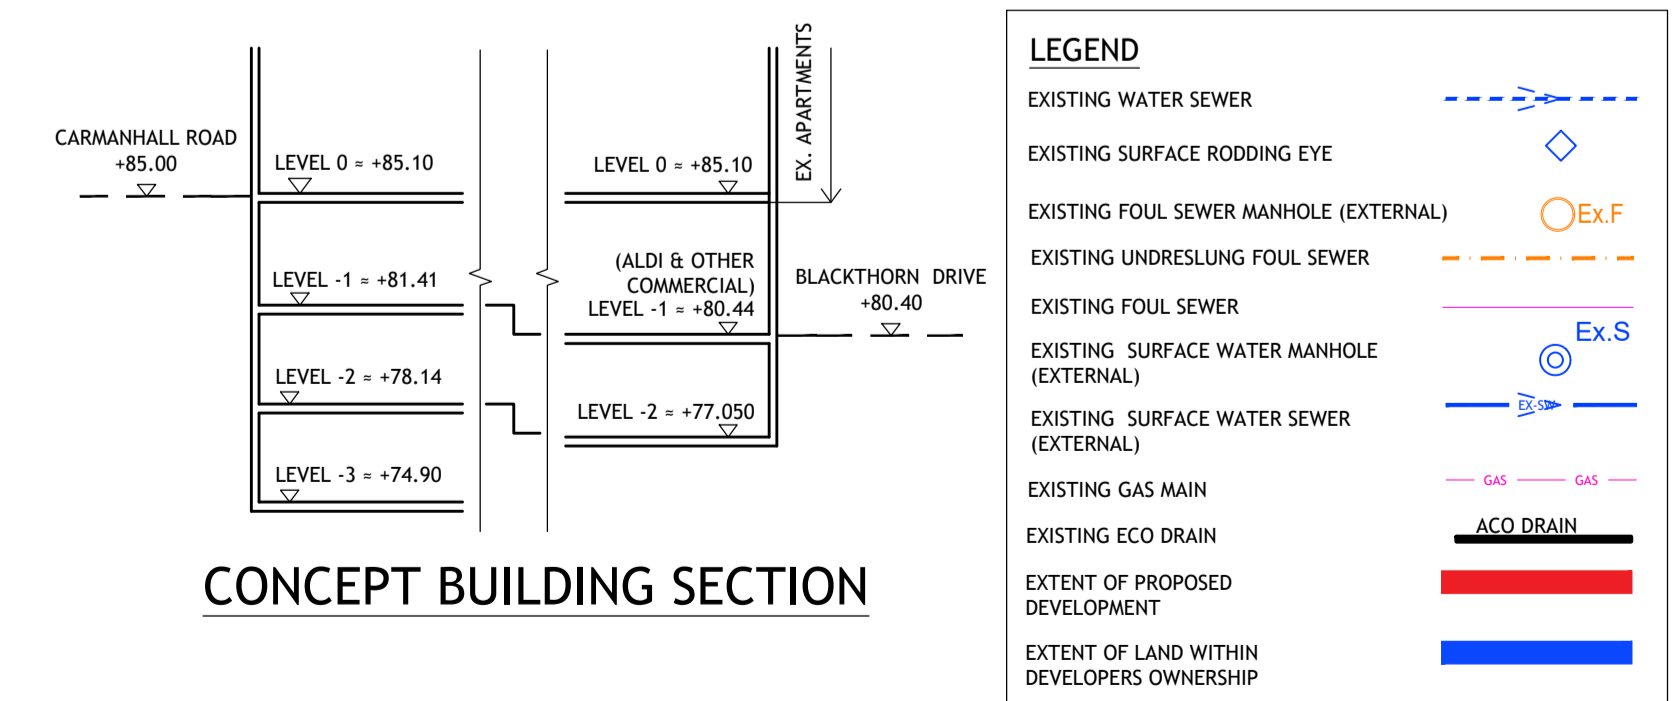

CONCEPT BUILDING SECTION

© PUNCH Consulting Engineers

This drawing and any design hereon is the copyright of the Consultants and must not be reproduced without their written consent. All drawings remain the property of the Consultants. Figured dimension only to be taken from this drawing. Consultants to be informed immediately of any discrepancies before work proceeds.



Date Drawn: JULY 2018
 Drawn By: IBS
 Date Issued: 2019/04/12
 Issued By: IBS



Rev	Amendment	By	Date
PL0	ISSUED FOR PLANNING	IBS	2018/12/06
PL1	ISSUED FOR PLANNING	IBS	2019/03/29
PL2	ISSUED FOR PLANNING	IBS	2019/04/12

Client:
IRES Residential Properties LTD.

Job: LANDS KNOWN AS "RB CENTRAL" AT ROCKBROOK, CARMANHALL ROAD, SANDYFORD BUSINESS DISTRICT, SANDYFORD, DUBLIN 18

Title: EXISTING DRAINAGE LAYOUT - BASEMENT -2 SH 2 OF 2

PUNCH consulting engineers
 Dublin | Limerick | Cork | Galway | Glasgow
 Carnegie House, Library Road, Dun Laoghaire, Co. Dublin, A96 C7W7
 IRL: +353 1 271 2200 www.punchconsulting.com

Stage: PLANNING
 Scale @ A1: 1:250
 Technician Check: IBS
 Engineer Check: MR
 Approved: PC
 Drawing No: 152217-065
 Rev: PL2