 
 



NOTES


1. WATER SERVICES AND FIRE HYDRANT LAYOUT IS INDICATIVE AND SUBJECT TO COORDINATION WITH LANDSCAPE LAYOUT



TYPICAL HYDRANT MARKER DETAIL
NOT TO SCALE - BY MAIN CONTRACTOR

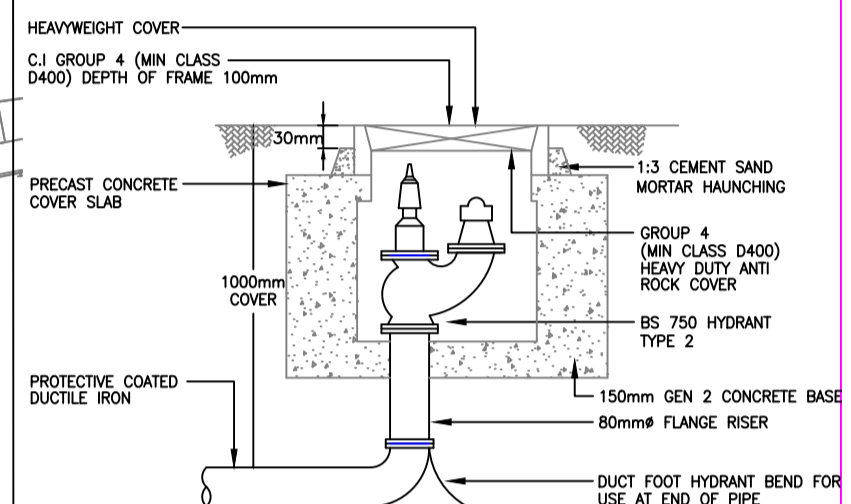


TYPICAL INDICATIVE FIRE HYDRANT
NOT TO SCALE

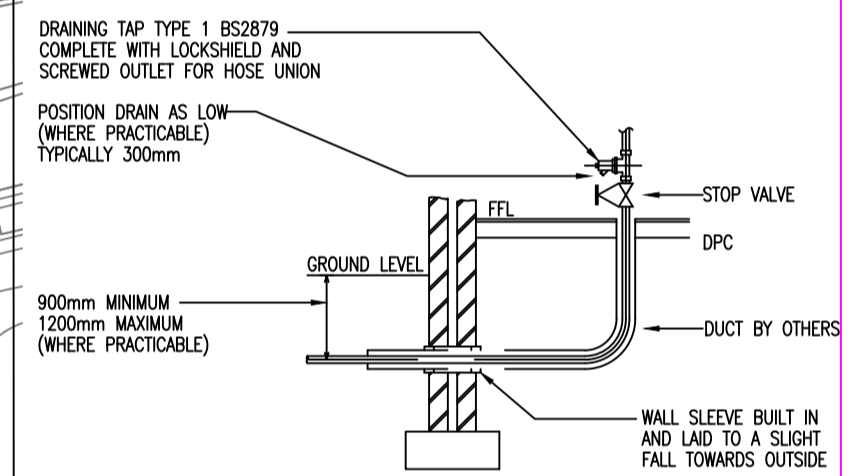


INCOMING MWS ENTRY DETAIL
NOT TO SCALE

H - FIRE HYDRANT

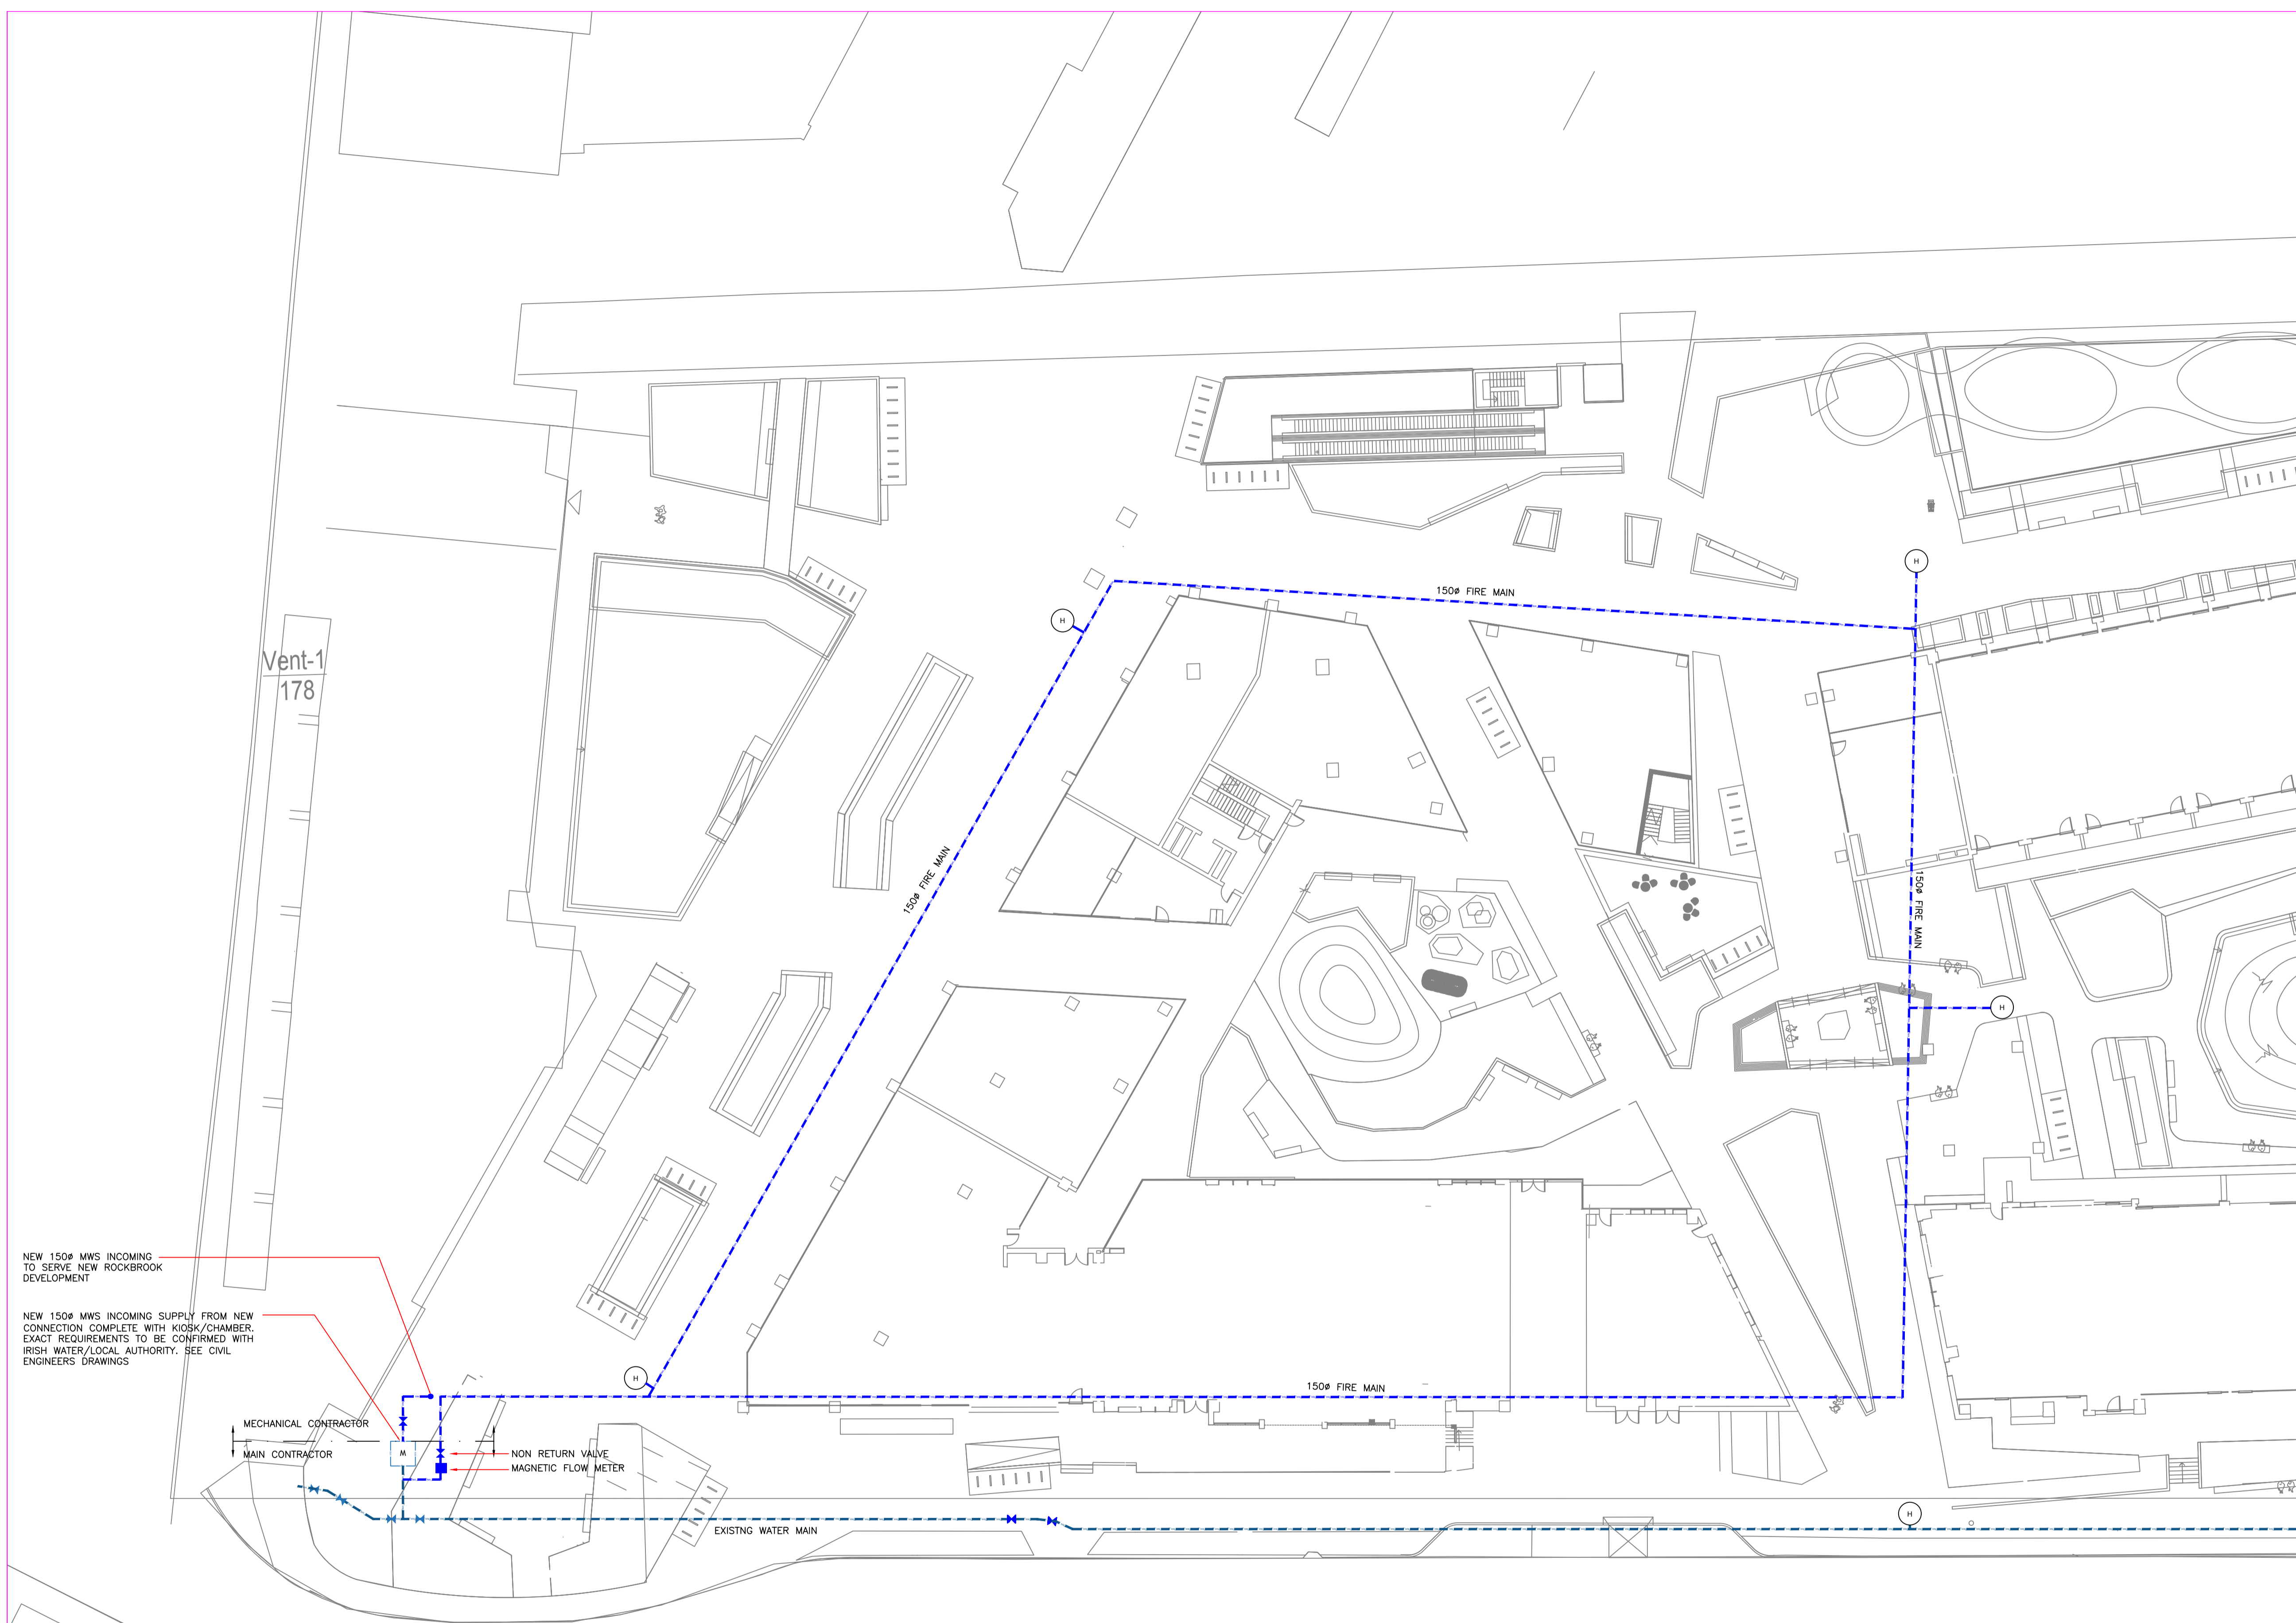

NEW 150mm MWS INCOMING TO SERVE NEW ROCKBROOK DEVELOPMENT

NEW 150mm MWS INCOMING SUPPLY FROM NEW CONNECTION COMPLETE WITH KIOSK/CHAMBER. EXACT REQUIREMENTS TO BE CONFIRMED WITH IRISH WATER/LOCAL AUTHORITY. SEE CIVIL ENGINEERS DRAWINGS

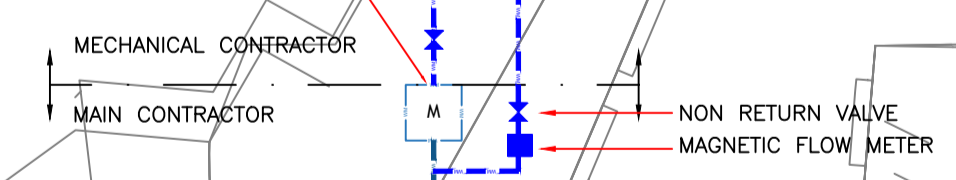


REV	DESCRIPTION	BY	APP	DATE
A	ISSUED FOR PLANNING	SD	BH	07/12/2018

THIS DOCUMENT IS COPYRIGHT AND THE PROPERTY OF McELROY ASSOCIATES. THIS DOCUMENT IS NOT TO BE REPRODUCED, MODIFIED OR RELAYED IN PART OR IN WHOLE TO ANY OTHER FIRM OR INDIVIDUAL WITHOUT THE PRIOR WRITTEN PERMISSION OF McELROY ASSOCIATES.

MFA McElroy Associates
MECHANICAL & ELECTRICAL

72 Haddington Road, Ballsbridge, Dublin 4. T: (01) 660 9000 F: (01) 660 9099 E: info@mea.ie W: www.mea.ie

DESIGNED: SD	CHECKED: IA	APPROVED: IA
DRAWN: SD	DATE: 10/11/2018	SCALE: 1:250 @ A1
DRG No: 18022-MP02	REV:	

<p>CLIENT:  IRES better living made simple</p>	<p>PROJECT: RB CENTRAL, ROCKBROOK ESTATE, SANDYFORD BUSINESS DISTRICT, DUBLIN 18</p>	<p>TITLE: WATER SERVICES AND FIRE MAIN LAYOUT SITE PLAN</p>
---	--	---